




**PLAN**  
SCALE A

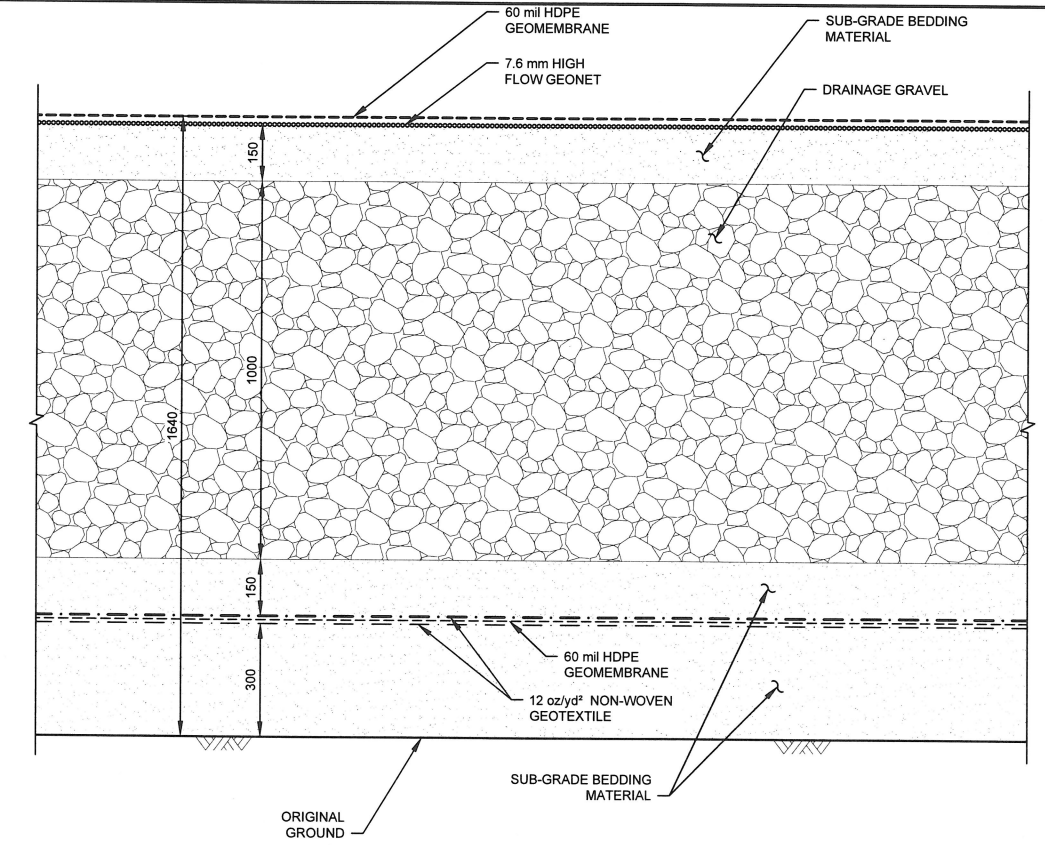

**A** **DETAIL**  
**SEEPAGE COLLECTION**  
**SUMP LINER DETAIL**  
N.T.S.

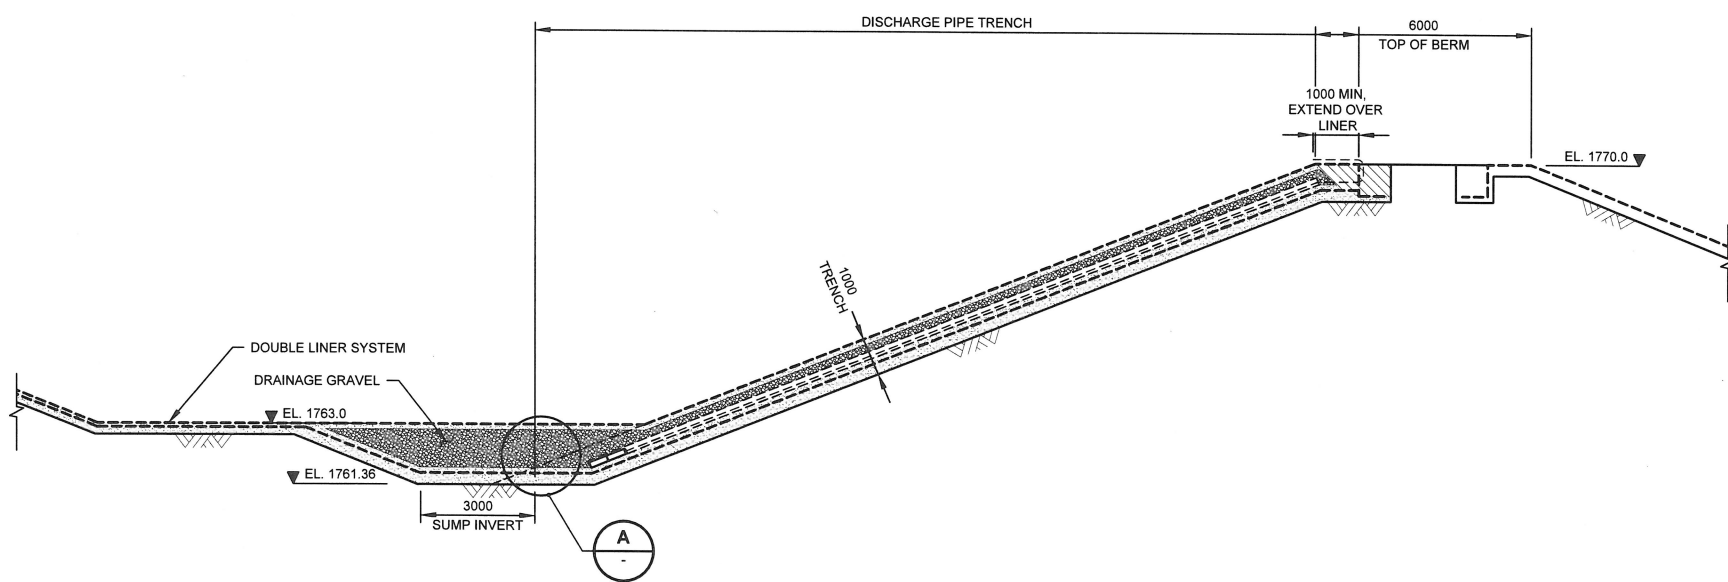


**1** **PROFILE**  
SCALE A

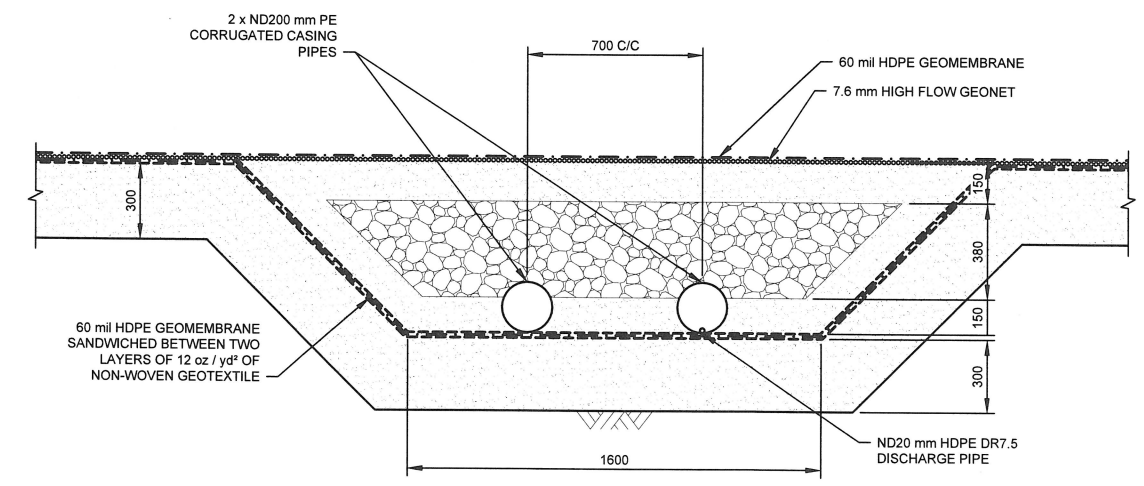

**2** **SECTION**  
**DISCHARGE PIPE TRENCH**  
N.T.S.

 **NOT FOR CONSTRUCTION**  
**FOR INFORMATION ONLY**



DISCLAIMER  
THIS DRAWING WAS PREPARED BY KNIGHT PIESOLD LTD. FOR THE ACCOUNT OF THE CLIENT LISTED ON THIS DRAWING. THE MATERIAL ON IT REFLECTS KNIGHT PIESOLD'S BEST JUDGEMENT IN THE LIGHT OF THE INFORMATION AVAILABLE TO IT AT THE TIME OF PREPARATION. ANY USE WHICH A THIRD PARTY MAKES OF THIS DRAWING, OR ANY RELIANCE ON OR DECISIONS TO BE MADE BASED ON IT, ARE THE RESPONSIBILITY OF SUCH THIRD PARTIES. KNIGHT PIESOLD ACCEPTS NO RESPONSIBILITY FOR DAMAGES, IF ANY, SUFFERED BY THE THIRD PARTY AS A RESULT OF DECISIONS MADE OR ACTIONS BASED ON THIS DRAWING. THIS DRAWING IS NOT TO BE USED FOR ANY OTHER PURPOSE WITHOUT THE WRITTEN PERMISSION OF KNIGHT PIESOLD.

**Knights Piesold**  
CONSULTING

TINTINA RESOURCES INC.

**BLACK BUTTE COPPER PROJECT**

**BRINE POND**  
**SEEPAGE COLLECTION AND**  
**RECYCLING SYSTEM**  
**PLAN, PROFILE, SECTION AND DETAIL**





VA101-460/3  
C9004  
1

SAVED: M:\11010046003\A\A\read\DWG\C9004\C9004.dwg, 9/10/2018 3:06:39 PM, RFAHAM PRINTED: 9/17/2018 2:42:50 PM, C9002, SCHIZAR


DRG. NO.	DESCRIPTION	REV	DATE	DESCRIPTION	DESIGNED	DRAWN	REVIEWED	APPROVED
C9003	CONTACT WATER POND - GENERAL ARRANGEMENT - SECTIONS AND DETAILS							
C9001	CONTACT WATER POND - GRADING PLAN							

REV	DATE	DESCRIPTION	DESIGNED	DRAWN	REVIEWED	APPROVED
1	17SEP'18	ISSUED FOR INFORMATION	GIM	RAF	KJB	KJB
0	29APR'16	ISSUED FOR INFORMATION	GIM	RAP	KJB	KJB

REV	DATE	DESCRIPTION	DESIGNED	DRAWN	REVIEWED	APPROVED
1	17SEP'18	ISSUED FOR INFORMATION	GIM	RAF	KJB	KJB
0	29APR'16	ISSUED FOR INFORMATION	GIM	RAP	KJB	KJB

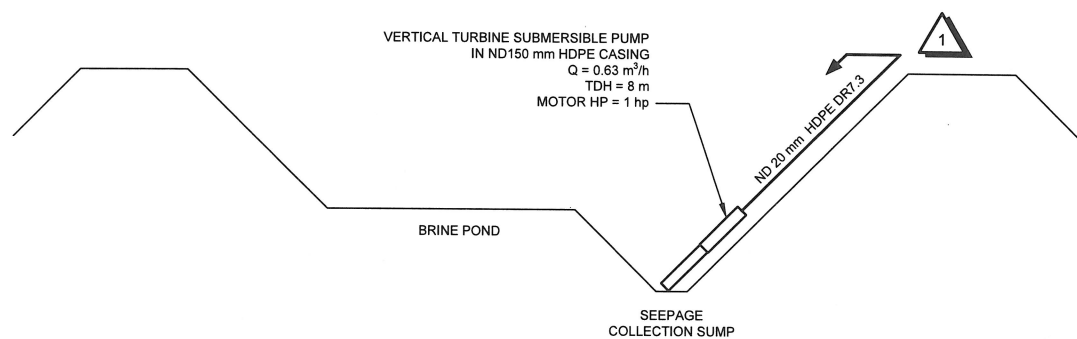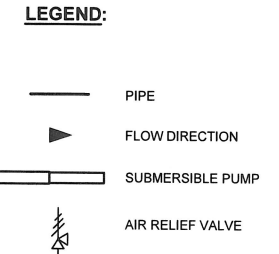

**BRINE POND SEEPAGE COLLECTION AND RECYCLE SYSTEM**

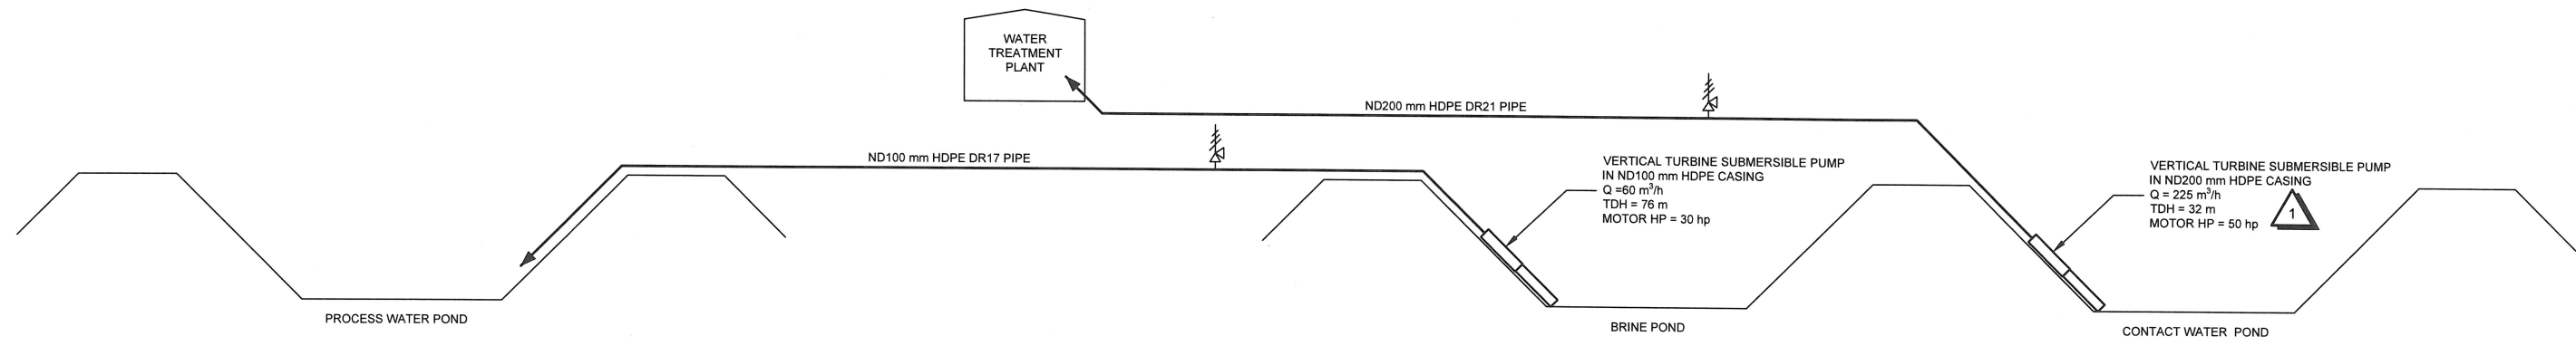

**BRINE AND CONTACT WATER RECLAIM SYSTEM**

**NOT FOR CONSTRUCTION  
FOR INFORMATION ONLY**


SAVED: M:\11010046\03\AA\lead\DWG\SI\C9005\C9005\_9/17/2018 2:40:59 PM, SCHIZAR PRINTED: 9/17/2018 2:41:56 PM, layout, SCHIZAR XREF FILE(S): IMAGE FILE(S):

C9003	BRINE & CONTACT WATER PONDS - G.A. - SECTION AND DETAILS
C9002	BRINE & CONTACT WATER PONDS - G.A. AND LINE SYSTEM LAYOUT - PLAN
DRG. NO.	DESCRIPTION
REFERENCE DRAWINGS	

REV	DATE	DESCRIPTION	DESIGNED	DRAWN	REVIEWED	APPROVED
REVISIONS						

REV	DATE	DESCRIPTION	DESIGNED	DRAWN	REVIEWED	APPROVED
1	17SEP'18	ISSUED FOR INFORMATION	GIM	RAF	KJB	KJB
0	29APR'16	ISSUED FOR INFORMATION	GIM	RAP	KJB	KJB
REVISIONS						

— DISCLAIMER —  
THIS DRAWING WAS PREPARED BY KNIGHT PIESOLD LTD. FOR THE ACCOUNT OF THE CLIENT LISTED ON THIS DRAWING. THE MATERIAL ON IT REFLECTS KNIGHT PIESOLD'S BEST JUDGEMENT IN THE LIGHT OF THE INFORMATION AVAILABLE TO IT AT THE TIME OF PREPARATION. ANY USE WHICH A THIRD PARTY MAKES OF THIS DRAWING, OR ANY RELIANCE ON OR DECISIONS TO BE MADE BASED ON IT, ARE THE RESPONSIBILITY OF SUCH THIRD PARTIES. KNIGHT PIESOLD ACCEPTS NO RESPONSIBILITY FOR DAMAGES, IF ANY, SUFFERED BY THE THIRD PARTY AS A RESULT OF DECISIONS MADE OR ACTIONS BASED ON THIS DRAWING. THIS DRAWING IS BEING TRANSMITTED FROM ELECTRONIC TRANSMISSION AND THEREFORE THE USER SHALL BE RESPONSIBLE FOR VERIFYING THE ACCURACY OF THE INFORMATION ON THIS DRAWING.

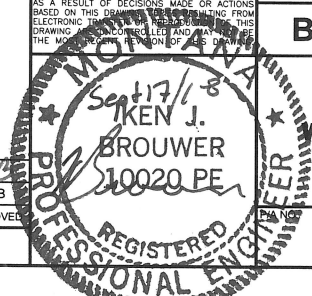

**Knight Piésold  
CONSULTING**

TINTINA RESOURCES INC.

**BLACK BUTTE COPPER PROJECT**

**BRINE AND CONTACT WATER POND  
WATER MANAGEMENT SYSTEM PIPING  
AND INSTRUMENTATION DIAGRAM**

VA101-460/3      C9005      1

## TRANSMITTAL

### Ongoing Support Work

<b>Date:</b>	September 17, 2018	<b>File No.:</b>	VA101-00460/06-A.01
		<b>Cont. No.:</b>	VA18-01782
<b>To:</b>	Sandfire Resources America Inc. (Vancouver) 1110 - 1111 West Georgia Street Vancouver, British Columbia Canada, V6E 4M3		
<b>Attention:</b>	Mr. Bob Jacko		

### Document Items

Item No.	Description
1.	1 Copy of Each – Drawings  C9004 Rev 1 C9005 Rev 1

### Remarks

<b>Remarks</b>	-
----------------	---

Prepared: \_\_\_\_\_ Reviewed: \_\_\_\_\_  
Matthew Ward Greg Magoon

/maw